


Engineering Services
of Vermont, LLC
9 Washington Street
Rutland, Vermont 05701
www.ENGINEERINGVERMONT.com
Phone: 802-855-8091

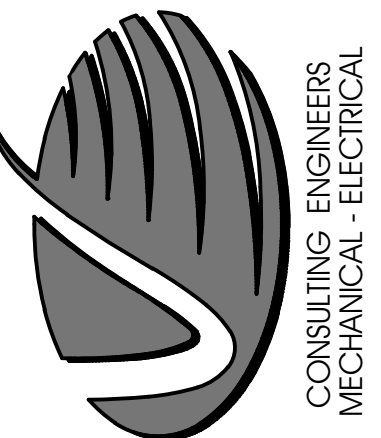


NO.	ISSUED FOR	DATE

TOWN OF BRANDON
2417 FRANKLIN STREET, BRANDON, VERMONT
TOWN OFFICES REHABILITATION
49 CENTER STREET, BRANDON, VERMONT
MECHANICAL AIR CONDITIONING
SECOND FLOOR PLAN

PROJ. NO: 15023
DRAWN: DWD
DATE: 8/3/2015

M4

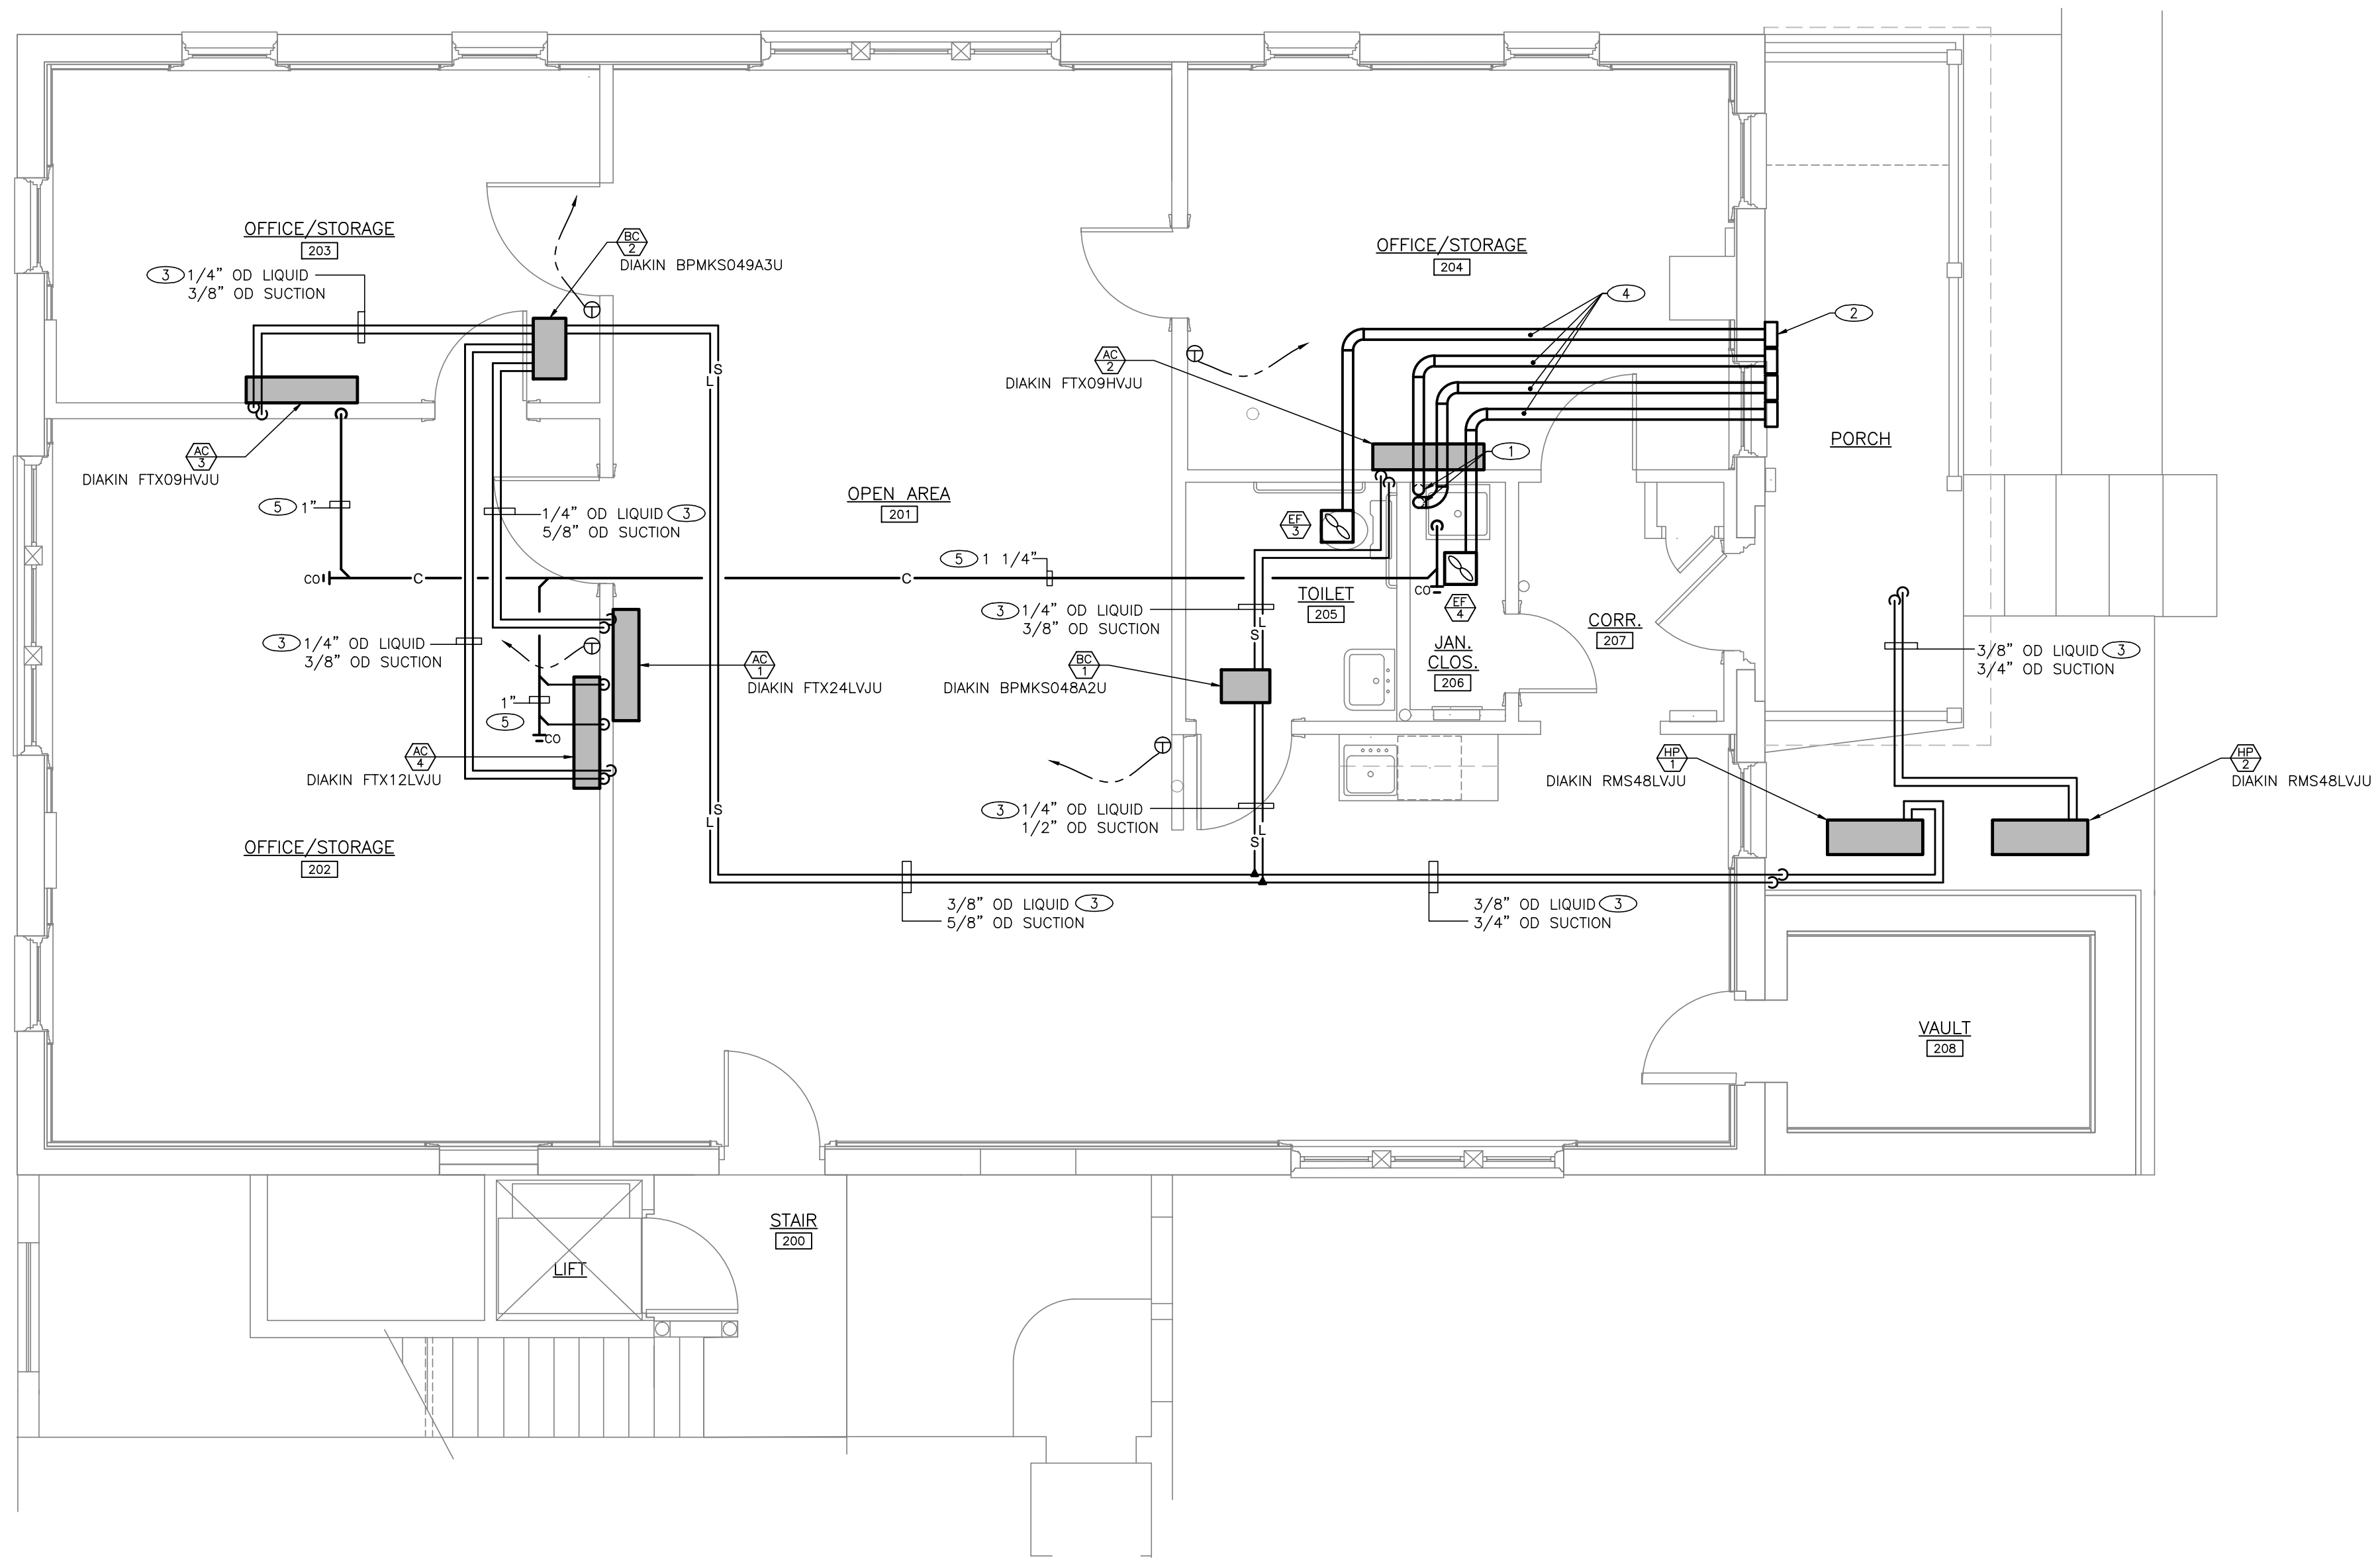

**MECHANICAL AIR CONDITIONING
SECOND FLOOR PLAN**
SCALE: 1/4"=1'-0"

- DRAWING NOTES:** (APPLY TO THIS DRAWING ONLY)
- ① 4" EXHAUST DUCT DOWN.
 - ② PROVIDE WALL CAP WITH BACKDRAFT DAMPER. TERMINATE AT LOCATION DIRECTED BY THE ARCHITECT.
 - ③ LOCATE REFRIGERANT PIPING IN ATTIC. FINAL LINE SIZING TO BE PROVIDED BY THE MANUFACTURER. INSULATE ALL REFRIGERANT PIPING WITH 1" THICK INSULATION.
 - ④ 4" EXHAUST DUCT IN ATTIC INSULATE WITH 3" THICK FOIL FACED FIBERGLASS DUCT WRAP.
 - ⑤ RUN CONDENSATE PIPING IN ATTIC, INSULATE WITH 1" ARMAFLEX, TERMINATE AT JANITORS SINK.